 


NOTES:

- 1.) ALL DIMENSIONS TO BE VERIFIED BY CONTRACTOR ON SITE PRIOR TO COMMENCEMENT OF ANY WORK.
- 2.) DO NOT SCALE THIS DRAWING FOR THE PURPOSE OF MEASUREMENT. ONLY SCALE DIMENSIONS WHERE SPECIFICALLY INSTRUCTED TO DO SO.
- 3.) ALL MEASUREMENTS ARE IN MILLIMETERS UNLESS OTHERWISE SPECIFIED.
- 4.) DIMENSIONS SHOWN ON THESE DRAWINGS ARE STRUCTURAL DIMENSIONS UNLESS CLEARLY NOTED OTHERWISE.
- 5.) THIS DRAWING IS TO BE READ IN CONJUNCTION WITH ALL OTHER DRAWINGS, DETAIL AND SPECIFICATIONS. ANY DISCREPANCY TO BE IMMEDIATELY BROUGHT TO THE ATTENTION OF ARCHITECT PRIOR TO COMMENCING THE WORKS.



FINAL SUBMISSION

BINGHATTI HOLDING LIMITED


 سلفرستون
 للإستشارات الهندسية
 SILVER STONE
 ENGINEERING CONSULTANTS



BINGHATTI

BINGHATTI CANAL


B + G + 3P + 10 FLOORS + MECH FLOOR
11 FLOORS + ROOF FLOOR.

DRAWING TITLE:

PROJECT NO:	DWG NO:	REV:
-------------	---------	------


P021-01	A102	0
---------	------	---

1 GROUND FLOOR PLAN
A102 SCALE - 1:150

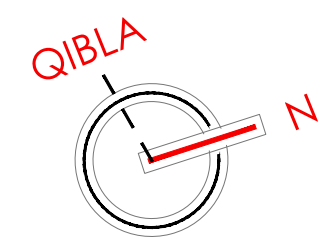

NOTES:

 - 1.) ALL DIMENSIONS TO BE VERIFIED BY CONTRACTOR ON SITE PRIOR TO COMMENCEMENT OF ANY WORK.
- 2.) DO NOT SCALE THIS DRAWING FOR THE PURPOSE OF MEASUREMENT. ONLY SCALE DIMENSIONS WHERE SPECIFICALLY INSTRUCTED TO DO SO.
- 3.) ALL MEASUREMENTS ARE IN MILLIMETERS UNLESS OTHERWISE SPECIFIED.
- 4.) DIMENSIONS SHOWN ON THESE DRAWINGS ARE STRUCTURAL DIMENSIONS UNLESS CLEARLY NOTED OTHERWISE.
- 5.) THIS DRAWING IS TO BE READ IN CONJUNCTION WITH ALL OTHER DRAWINGS, DETAIL AND SPECIFICATIONS. ANY DISCREPANCY TO BE IMMEDIATELY BROUGHT TO THE ATTENTION OF ARCHITECT PRIOR TO COMMENCING THE WORKS.



REV	DATE	DESCRIPTION	CHECK

FINAL SUBMISSION

OWNER: _____

BINGHATTI HOLDING LIMITED

CONSULTANT:

 سلفر ستون
الاستشارات الهندسية
SILVER STONE
ENGINEERING CONSULTANTS

PROJECT :



BINGHATTI CANAL

B + G + 3P + 10 FLOORS + MECH FLOOR +
11 FLOORS + ROOF FLOOR.


PLOT NO. 3460664		LOCATION: BUSINESS BAY	
ARCH: AMAR M		STR Engg: M FLAHA	
Reg. No: 114763		Reg. No: 109115	
DRAWN: SS	CHECKED: AM	APPROVED: AM	

DRAWING TITLE:

PODIUM-1 FLOOR PLAN


PROJECT NO: P021-01	DWG NO: A103	REV: 0
-------------------------------	------------------------	------------------

1 PODIUM-1 FLOOR PLAN
A103 SCALE - 1:150

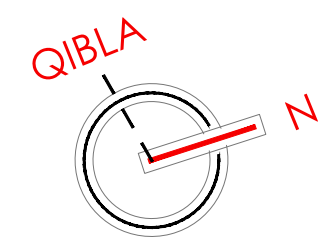

NOTES:

 - 1.) ALL DIMENSIONS TO BE VERIFIED BY CONTRACTOR ON SITE PRIOR TO COMMENCEMENT OF ANY WORK.
- 2.) DO NOT SCALE THIS DRAWING FOR THE PURPOSE OF MEASUREMENT. ONLY SCALE DIMENSIONS WHERE SPECIFICALLY INSTRUCTED TO DO SO.
- 3.) MEASUREMENTS ARE IN MILLIMETERS UNLESS OTHERWISE SPECIFIED.
- 4.) DIMENSIONS SHOWN ON THESE DRAWINGS ARE STRUCTURAL DIMENSIONS UNLESS CLEARLY NOTED OTHERWISE.
- 5.) THIS DRAWING IS TO BE READ IN CONJUNCTION WITH ALL OTHER DRAWINGS, DETAIL AND SPECIFICATIONS. ANY DISCREPANCY TO BE IMMEDIATELY BROUGHT TO THE ATTENTION OF ARCHITECT PRIOR TO COMMENCING THE WORKS.



REV	DATE	DESCRIPTION	CHECK

FINAL SUBMISSION

OWNER:

BINGHATTI HOLDING LIMITED

CONSULTANT:



PROJECT :



BINGHATTI CANAL

B + G + 3P + 10 FLOORS + MECH FLOOR
11 FLOORS + ROOF FLOOR.


PLOT NO. 3460664		LOCATION: BUSINESS BAY	
ARCH: AMAR M		STR Engg: M FLAHA	
Reg. No: 114763		Reg. No: 109115	
DRAWN: SS	CHECKED: AM	APPROVED: AM	

DRAWING TITLE:

PODIUM-2 FLOOR PLAN

PROJECT NO: P021-01	DWG NO: A104	REV: 0
-------------------------------	------------------------	------------------

NEIGHBOR PLOT

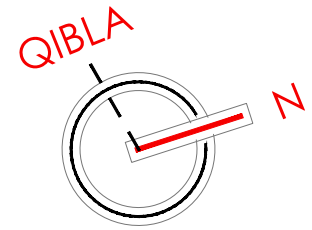

- APPROVAL STAMP:
- NOTES:
- 1.) ALL DIMENSIONS TO BE VERIFIED BY CONTRACTOR ON SITE PRIOR TO COMMENCEMENT OF ANY WORK.
 - 2.) DO NOT SCALE THIS DRAWING FOR THE PURPOSE OF MEASUREMENT. ONLY SCALE DIMENSIONS WHERE SPECIFICALLY INSTRUCTED TO DO SO.
 - 3.) ALL MEASUREMENTS ARE IN MILLIMETERS UNLESS OTHERWISE SPECIFIED.
 - 4.) DIMENSIONS SHOWN ON THESE DRAWINGS ARE STRUCTURAL DIMENSIONS UNLESS CLEARLY NOTED OTHERWISE.
 - 5.) THIS DRAWING IS TO BE READ IN CONJUNCTION WITH ALL OTHER DRAWINGS, DETAIL AND SPECIFICATIONS. ANY DISCREPANCY TO BE IMMEDIATELY BROUGHT TO THE ATTENTION OF ARCHITECT PRIOR TO COMMENCING THE WORKS.



GATE LEVEL PROPOSED = (+0.00 m.) = +3.977 m. DMD LVL.

REV DATE DESCRIPTION CHECK

STATUS: FINAL SUBMISSION

OWNER: BINGHATTI HOLDING LIMITED

CONSULTANT: SILVER STONE ENGINEERING CONSULTANTS


PROJECT: BINGHATTI CANAL
8 + G + 3P + 10 FLOORS + MECH FLOOR + 11 FLOORS + ROOF FLOOR.

PLOT NO. 3460664 LOCATION: BUSINESS BAY
ARCH: AMAR M STR Engg: M FLAHA
Reg. No: 114763 Reg. No: 109115
DRAWN: SS CHECKED: AM APPROVED: AM

DRAWING TITLE:


1ST FLOOR PLAN

PROJECT NO: P021-01 DWG NO: A106 REV: 0

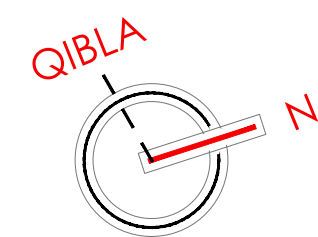

NOTES:

 - 1.) ALL DIMENSIONS TO BE VERIFIED BY CONTRACTOR ON SITE PRIOR TO COMMENCEMENT OF ANY WORK.
- 2.) DO NOT SCALE THIS DRAWING FOR THE PURPOSE OF MEASUREMENT. ONLY SCALE DIMENSIONS WHERE SPECIFICALLY INSTRUCTED TO DO SO.
- 3.) ALL MEASUREMENTS ARE IN MILLIMETERS UNLESS OTHERWISE SPECIFIED.
- 4.) DIMENSIONS SHOWN ON THESE DRAWINGS ARE STRUCTURAL DIMENSIONS UNLESS CLEARLY NOTED OTHERWISE.
- 5.) THIS DRAWING IS TO BE READ IN CONJUNCTION WITH ALL OTHER DRAWINGS, DETAIL AND SPECIFICATIONS. ANY DISCREPANCY TO BE IMMEDIATELY BROUGHT TO THE ATTENTION OF ARCHITECT PRIOR TO COMMENCING THE WORKS.



REV	DATE	DESCRIPTION	CHECK
STATUS :			

FINAL SUBMISSION

OWNER:

BINGHATTI HOLDING LIMITED

CONSULTANT:



PROJECT :



BINGHATTI CANAL


B + G + 3P + 10 FLOORS + MECH FLOOR
11 FLOORS + ROOF FLOOR.

PLOT NO. 3460664		LOCATION: BUSINESS BAY	
ARCH: AMAR M		STR Engg: M FLAHA	
Reg. No: 114763		Reg. No: 109115	
DRAWN: SS	CHECKED: AM	APPROVED: AM	

DRAWING TITLE:


SECOND FLOOR PLAN

PROJECT NO: P021-01	DWG NO: A107	REV: 0
-------------------------------	------------------------	------------------

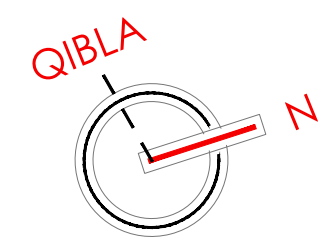

NOTES:

 - 1.) ALL DIMENSIONS TO BE VERIFIED BY CONTRACTOR ON SITE PRIOR TO COMMENCEMENT OF ANY WORK.
- 2.) DO NOT SCALE THIS DRAWING FOR THE PURPOSE OF MEASUREMENT. ONLY SCALE DIMENSIONS WHERE SPECIFICALLY INSTRUCTED TO DO SO.
- 3.) ALL MEASUREMENTS ARE IN MILLIMETERS UNLESS OTHERWISE SPECIFIED.
- 4.) DIMENSIONS SHOWN ON THESE DRAWINGS ARE STRUCTURAL DIMENSIONS UNLESS CLEARLY NOTED OTHERWISE.
- 5.) THIS DRAWING IS TO BE READ IN CONJUNCTION WITH ALL OTHER DRAWINGS, DETAIL AND SPECIFICATIONS. ANY DISCREPANCY TO BE IMMEDIATELY BROUGHT TO THE ATTENTION OF ARCHITECT PRIOR TO COMMENCING THE WORKS.



REV	DATE	DESCRIPTION	CHECK
STATUS :			

FINAL SUBMISSION

OWNER:

BINGHATTI HOLDING LIMITED

CONSULTANT:



PROJECT :



BINGHATTI CANAL


B + G + 3P + 10 FLOORS + MECH FLOOR
11 FLOORS + ROOF FLOOR.

PLOT NO: 3460664		LOCATION: BUSINESS BAY	
ARCH: AMAR M		STR Engg: M FLAHA	
Reg. No: 114763		Reg. No: 109115	
DRAWN: SS	CHECKED: AM	APPROVED: AM	

DRAWING TITLE:


TYPICAL 3rd,5th,7th,9th FLOOR PLAN

PROJECT NO: P021-01	DWG NO: A108	REV: 0
-------------------------------	------------------------	------------------

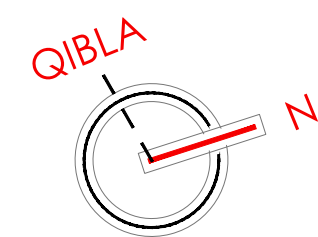

NOTES:

 - 1.) ALL DIMENSIONS TO BE VERIFIED BY CONTRACTOR ON SITE PRIOR TO COMMENCEMENT OF ANY WORK.
- 2.) DO NOT SCALE THIS DRAWING FOR THE PURPOSE OF MEASUREMENT. ONLY SCALE DIMENSIONS WHERE SPECIFICALLY INSTRUCTED TO DO SO.
- 3.) MEASUREMENTS ARE IN MILLIMETERS UNLESS OTHERWISE SPECIFIED.
- 4.) DIMENSIONS SHOWN ON THESE DRAWINGS ARE STRUCTURAL DIMENSIONS UNLESS CLEARLY NOTED OTHERWISE.
- 5.) THIS DRAWING IS TO BE READ IN CONJUNCTION WITH ALL OTHER DRAWINGS, DETAIL AND SPECIFICATIONS. ANY DISCREPANCY TO BE IMMEDIATELY BROUGHT TO THE ATTENTION OF ARCHITECT PRIOR TO COMMENCING THE WORKS.



REV	DATE	DESCRIPTION	CHECK

STATUS : **FINAL SUBMISSION**

OWNER:

BINGHATTI HOLDING LIMITED

CONSULTANT:

 سلفر ستون
الاستشارات الهندسية
SILVER STONE
ENGINEERING CONSULTANTS

PROJECT :



BINGHATTI CANAL

B + G + 3P + 10 FLOORS + MECH FLOOR +
11 FLOORS + ROOF FLOOR.

PLOT NO. 3460664		LOCATION: BUSINESS BAY	
ARCH: AMAR M		STR Engg: M FLAHA	
Reg. No: 114763		Reg. No: 109115	
DRAWN: SS	CHECKED: AM	APPROVED: AM	


DRAWING TITLE:

**TYPICAL 4TH,6TH,8TH,10TH
FLOOR PLAN**

PROJECT NO: P021-01	DWG NO: A109	REV: 0
-------------------------------	------------------------	------------------

1 TYPICAL FLOOR TYPE-2
A109 SCALE - 1:150

NEIGHBOR PLOT

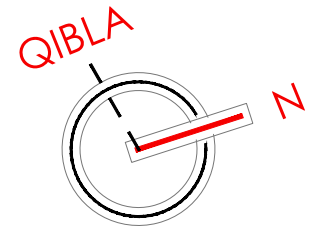

APPROVAL STAMP:

- NOTES:
- 1.) ALL DIMENSIONS TO BE VERIFIED BY CONTRACTOR ON SITE PRIOR TO COMMENCEMENT OF ANY WORK.
 - 2.) DO NOT SCALE THIS DRAWING FOR THE PURPOSE OF MEASUREMENT. ONLY SCALE DIMENSIONS WHERE SPECIFICALLY INSTRUCTED TO DO SO.
 - 3.) ALL MEASUREMENTS ARE IN MILLIMETERS UNLESS OTHERWISE SPECIFIED.
 - 4.) DIMENSIONS SHOWN ON THESE DRAWINGS ARE STRUCTURAL DIMENSIONS UNLESS CLEARLY NOTED OTHERWISE.
 - 5.) THIS DRAWING IS TO BE READ IN CONJUNCTION WITH ALL OTHER DRAWINGS, DETAIL AND SPECIFICATIONS. ANY DISCREPANCY TO BE IMMEDIATELY BROUGHT TO THE ATTENTION OF ARCHITECT PRIOR TO COMMENCING THE WORKS.



GATE LEVEL PROPOSED = (+0.00 m.) = +3.977 m. DMD LVL.

REV DATE DESCRIPTION CHECK

STATUS:

FINAL SUBMISSION

OWNER:

BINGHATTI HOLDING LIMITED



PROJECT:

BINGHATTI CANAL
B + G + 3P + 10 FLOORS + MECH FLOOR + 11 FLOORS + ROOF FLOOR.

PLOT NO. 3460664 LOCATION: BUSINESS BAY

ARCH: AMAR M STR Engg: M FLAHA

Reg. No: 114763 Reg. No: 109115

DRAWN: SS CHECKED: AM APPROVED: AM

DRAWING TITLE:



MECHANICAL FLOOR PLAN

PROJECT NO: DWG NO: REV:

P021-01 A110 0

1 TYPICAL FLOOR TYPE-3
A111 SCALE: 1:150

NEIGHBOR PLOT

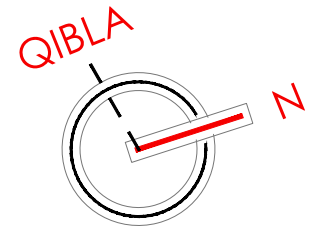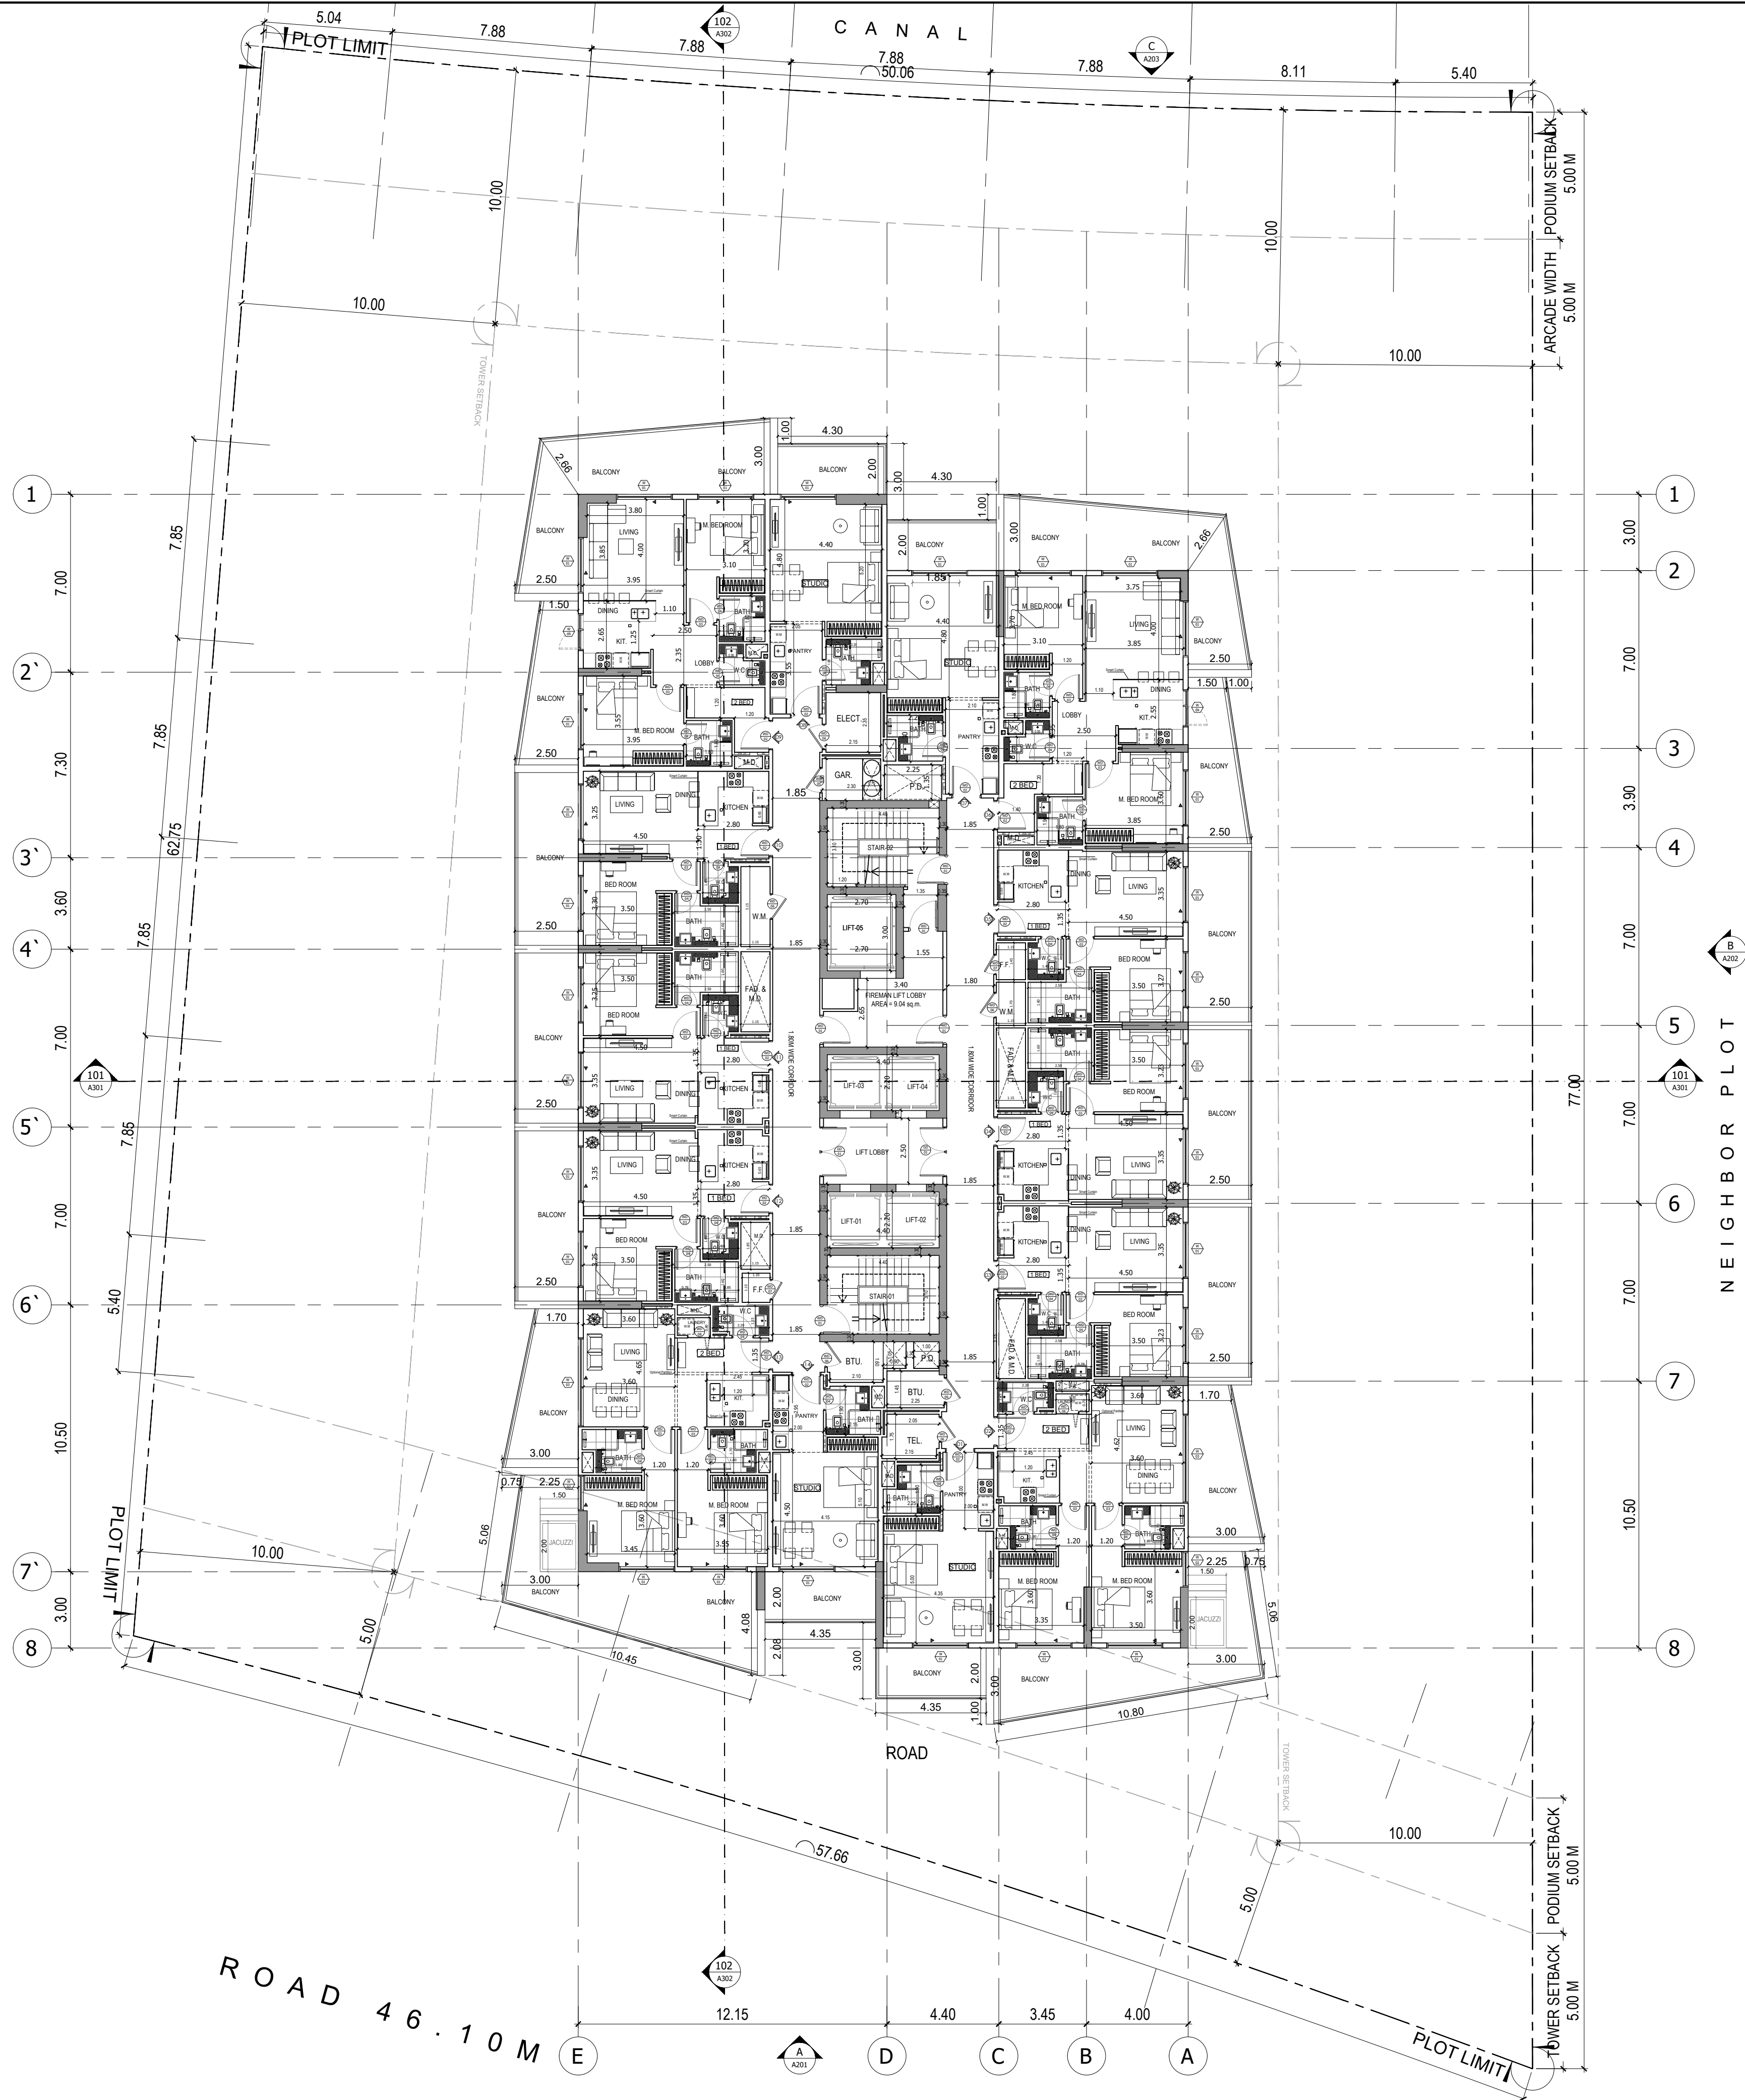

- APPROVAL STAMP:
- NOTES:
- 1.) ALL DIMENSIONS TO BE VERIFIED BY CONTRACTOR ON SITE PRIOR TO COMMENCEMENT OF ANY WORK.
 - 2.) DO NOT SCALE THIS DRAWING FOR THE PURPOSE OF MEASUREMENT. ONLY SCALE DIMENSIONS WHERE SPECIFICALLY INSTRUCTED TO DO SO.
 - 3.) ALL MEASUREMENTS ARE IN MILLIMETERS UNLESS OTHERWISE SPECIFIED.
 - 4.) DIMENSIONS SHOWN ON THESE DRAWINGS ARE STRUCTURAL DIMENSIONS UNLESS CLEARLY NOTED OTHERWISE.
 - 5.) THIS DRAWING IS TO BE READ IN CONJUNCTION WITH ALL OTHER DRAWINGS, DETAIL AND SPECIFICATIONS. ANY DISCREPANCY TO BE IMMEDIATELY BROUGHT TO THE ATTENTION OF ARCHITECT PRIOR TO COMMENCING THE WORKS.



GATE LEVEL PROPOSED = (+0.00 m.) = +3.977 m. DMD LVL.

REV DATE DESCRIPTION CHECK

STATUS: FINAL SUBMISSION

OWNER: BINGHATTI HOLDING LIMITED




PROJECT: BINGHATTI CANAL
8 + G + 3P + 10 FLOORS + MECH FLOOR + 11 FLOORS + ROOF FLOOR.

PLOT NO: 3460664 LOCATION: BUSINESS BAY
ARCH: AMAR M STR Engg: M FLAHA
Reg. No: 114763 Reg. No: 109115
DRAWN: SS CHECKED: AM APPROVED: AM


DRAWING TITLE: TYPICAL 11TH, 13TH, 15TH, 17TH, 19TH FLOORS PLAN

PROJECT NO: P021-01 DWG NO: A111 REV: 0

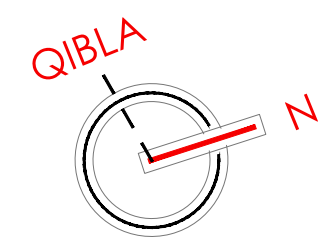

NOTES:

 - 1.) ALL DIMENSIONS TO BE VERIFIED BY CONTRACTOR ON SITE PRIOR TO COMMENCEMENT OF ANY WORK.
- 2.) DO NOT SCALE THIS DRAWING FOR THE PURPOSE OF MEASUREMENT. ONLY SCALE DIMENSIONS WHERE SPECIFICALLY INSTRUCTED TO DO SO.
- 3.) MEASUREMENTS ARE IN MILLIMETERS UNLESS OTHERWISE SPECIFIED.
- 4.) DIMENSIONS SHOWN ON THESE DRAWINGS ARE STRUCTURAL DIMENSIONS UNLESS CLEARLY NOTED OTHERWISE.
- 5.) THIS DRAWING IS TO BE READ IN CONJUNCTION WITH ALL OTHER DRAWINGS, DETAIL AND SPECIFICATIONS. ANY DISCREPANCY TO BE IMMEDIATELY BROUGHT TO THE ATTENTION OF ARCHITECT PRIOR TO COMMENCING THE WORKS.



REV	DATE	DESCRIPTION	CHECK
-----	------	-------------	-------

STATUS: **FINAL SUBMISSION**

OWNER:

BINGHATTI HOLDING LIMITED

CONSULTANT:



PROJECT :



BINGHATTI CANAL

B + G + 3P + 10 FLOORS + MECH FLOOR
11 FLOORS + ROOF FLOOR.


PLOT NO. 3460664		LOCATION: BUSINESS BAY	
ARCH: AMAR M		STR Engg: M FLAHA	
Reg. No: 114763		Reg. No: 109115	
DRAWN: SS	CHECKED: AM	APPROVED: AM	

DRAWING TITLE:

**TYPICAL 12TH,14TH,16TH,18TH,20TH
FLOORS PLAN**


PROJECT NO:	DWG NO:	REV:
P021-01	A112	0

1 TYPICAL FLOOR TYPE-4
A112 SCALE - 1:150

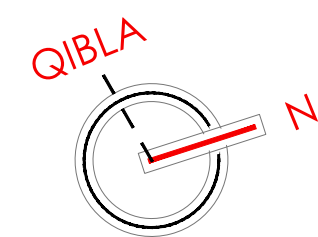

NOTES:

 - 1.) ALL DIMENSIONS TO BE VERIFIED BY CONTRACTOR ON SITE PRIOR TO COMMENCEMENT OF ANY WORK.
- 2.) DO NOT SCALE THIS DRAWING FOR THE PURPOSE OF MEASUREMENT. ONLY SCALE DIMENSIONS WHERE SPECIFICALLY INSTRUCTED TO DO SO.
- 3.) MEASUREMENTS ARE IN MILLIMETERS UNLESS OTHERWISE SPECIFIED.
- 4.) DIMENSIONS SHOWN ON THESE DRAWINGS ARE STRUCTURAL DIMENSIONS UNLESS CLEARLY NOTED OTHERWISE.
- 5.) THIS DRAWING IS TO BE READ IN CONJUNCTION WITH ALL OTHER DRAWINGS, DETAIL AND SPECIFICATIONS. ANY DISCREPANCY TO BE IMMEDIATELY BROUGHT TO THE ATTENTION OF ARCHITECT PRIOR TO COMMENCING THE WORKS.



FINAL SUBMISSION

OWNER: _____

BINGHATTI HOLDING LIMITED

CONSULTANT:

 سلفر ستون
الاستشارات الهندسية
SILVER STONE
ENGINEERING CONSULTANTS

PROJECT :



BINGHATTI CANAL

B + G + 3P + 10 FLOORS + MECH FLOOR +
11 FLOORS + ROOF FLOOR.

PLOT NO. 3460664		LOCATION: BUSINESS BAY	
ARCH: AMAR M		STR Engg: M FLAHA	
Reg. No: 114763		Reg. No: 109115	
DRAWN: SS	CHECKED: AM	APPROVED: AM	

DRAWING TITLE:

21ST FLOOR PLAN		
PROJECT NO: P021-01	DWG NO: A113	REV: 0